


LUMINAIRE SCHEDULE									
Symbol	Label	Qty	Catalog Number	Description	Lamp	File	Lumens	LLF	Watts
	A	18	TWH 400M	GENERAL PURPOSE BUILDING MOUNTED LUMINAIRE, 400W IHL, W/ CLEAR LAMP.	ONE 400 WATT CLEAR ED28 PULSE START METAL HALIDE IN HORIZONTAL POSITION	TWH_400M.ies	38000	1.00	456
	B	9	607AZ (42TRT)	6" OPEN DOWNLIGHT WITH SPECULAR REFLECTOR.	ONE 42-WATT TRIPLE TUBE COMPACT FLUORESCENT, VERTICAL BASE UP POSITION.	607AZ_42TRT.ies	3200	1.00	48

STATISTICS						
Description	Symbol	Avg	Max	Min	Max/Min	Avg/Min
Calc Zone #2	+	2.3 fc	7.4 fc	0.2 fc	37.0:1	115:1

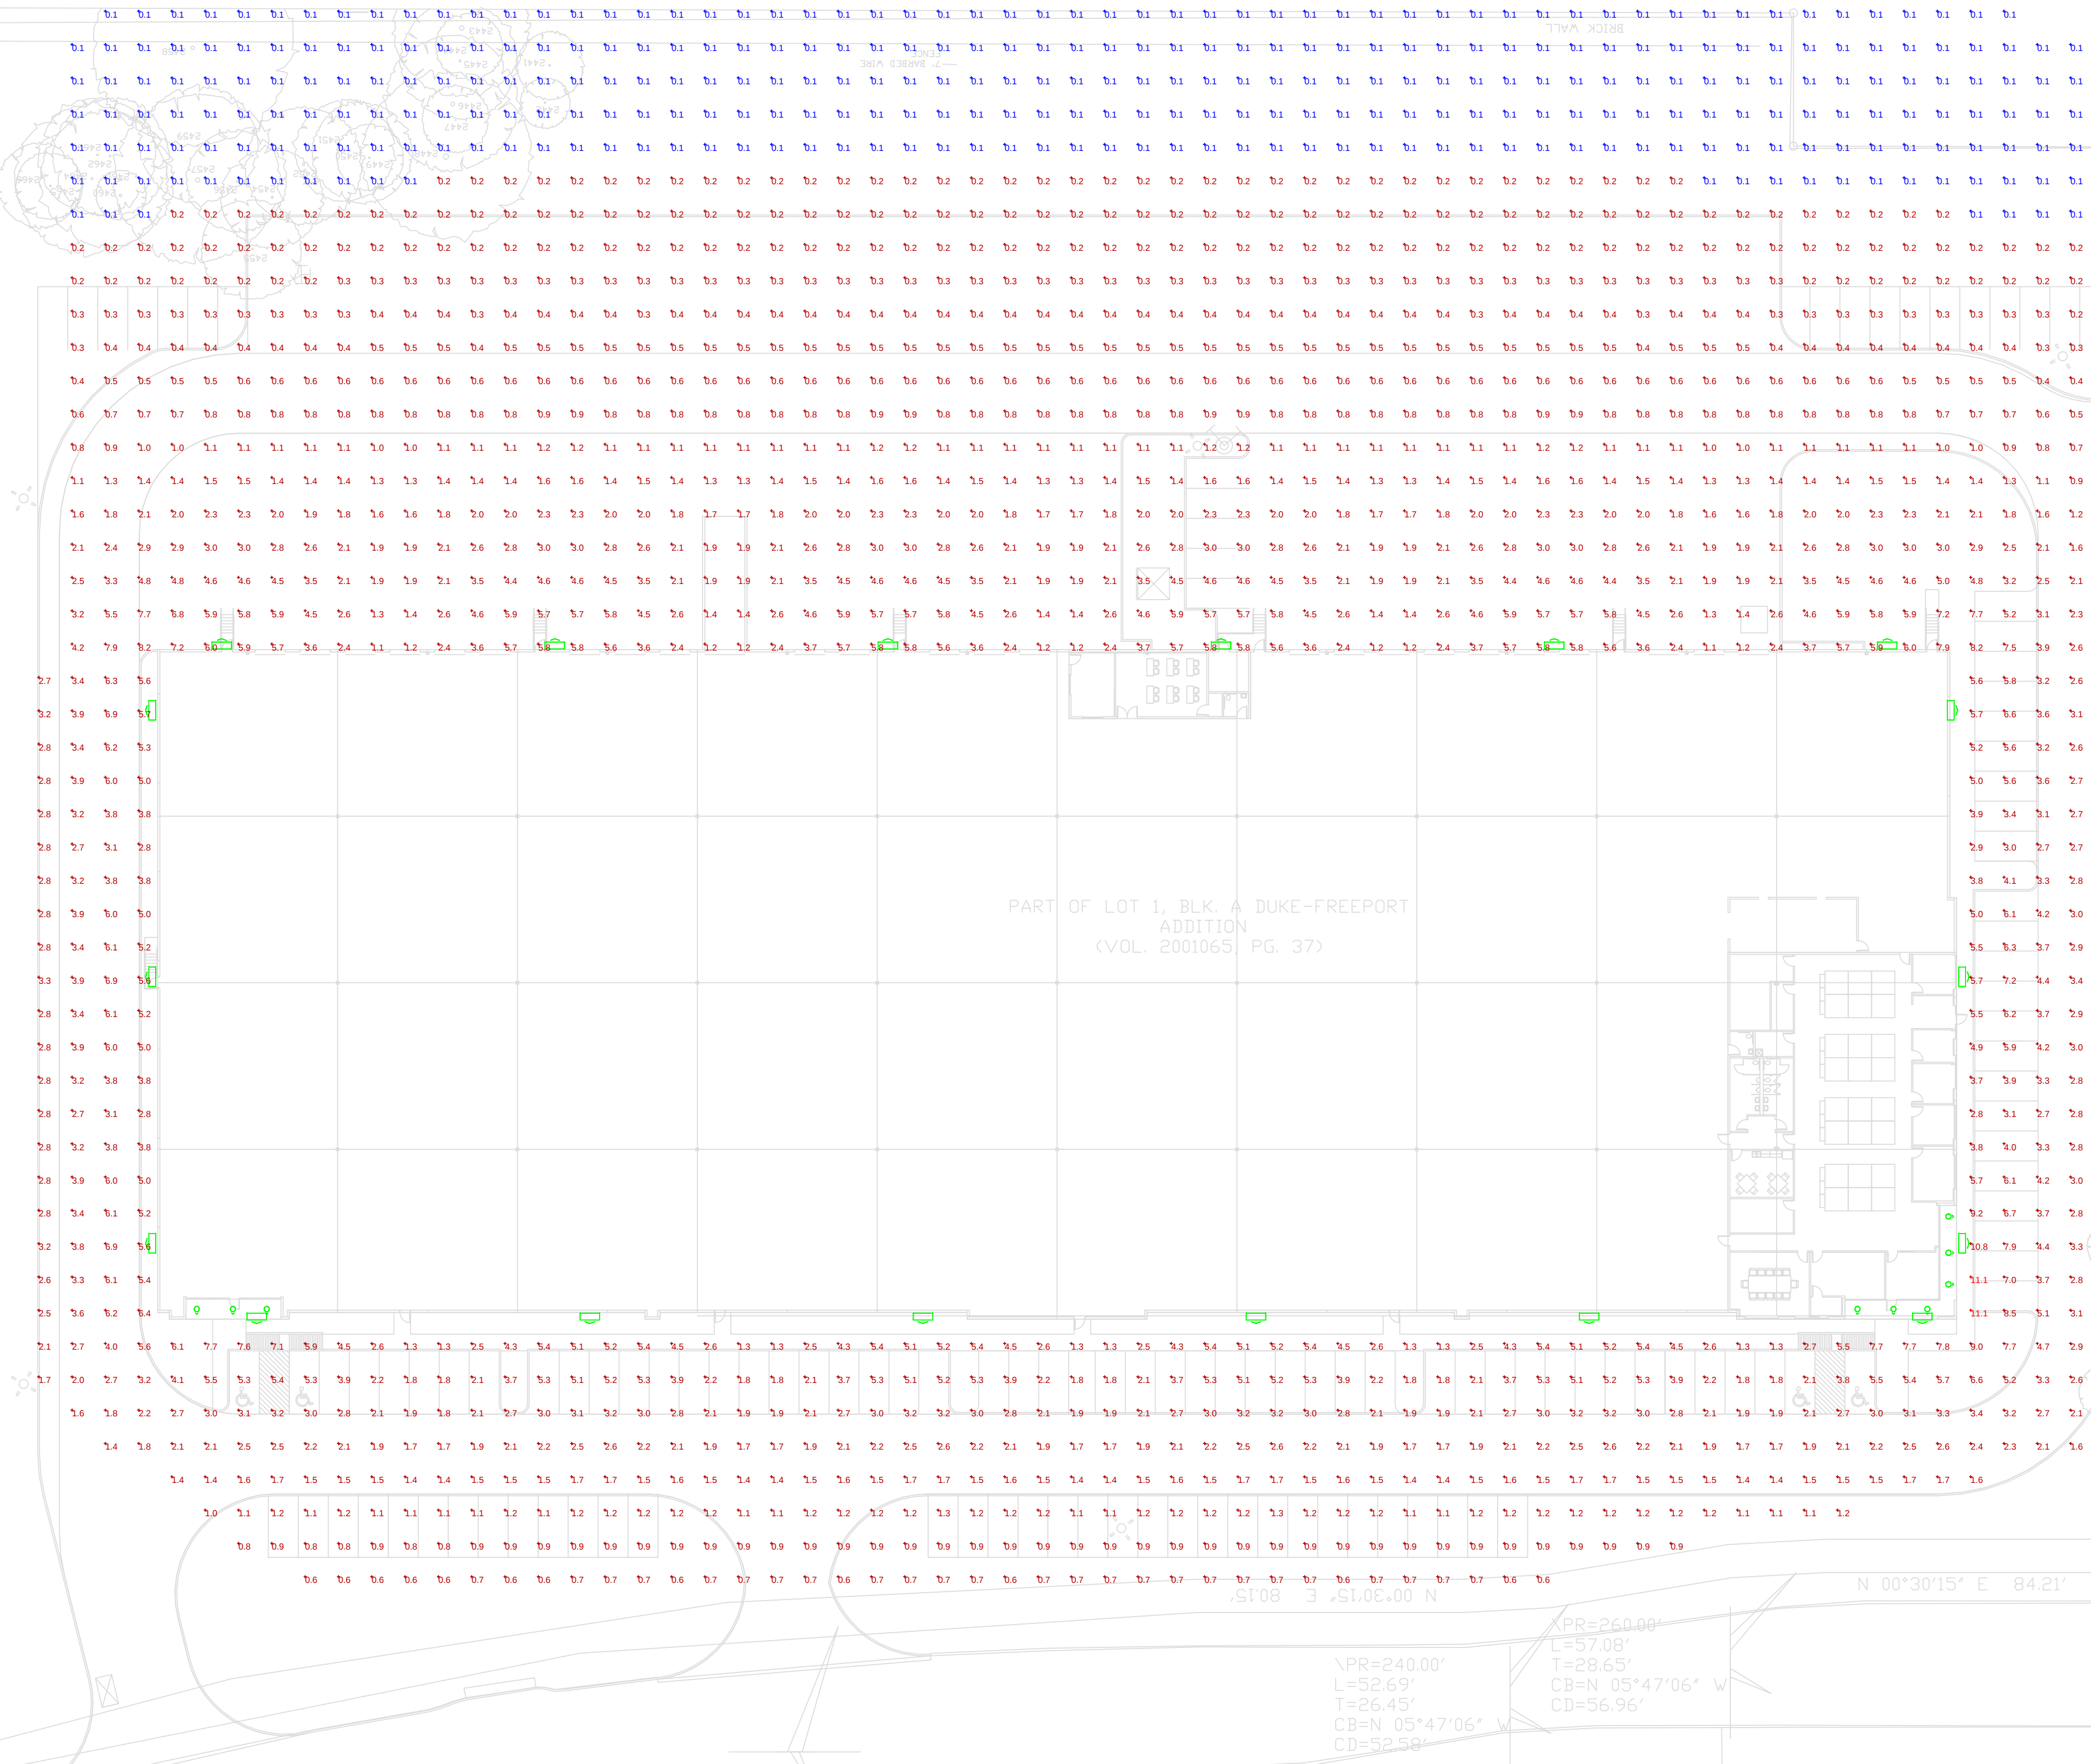

Plan View
Scale: 1" = 30'

TOHATSU

Designer
IK
Date
Dec 07 2015
Scale
SHOWN
Drawing No.

1 of 1