


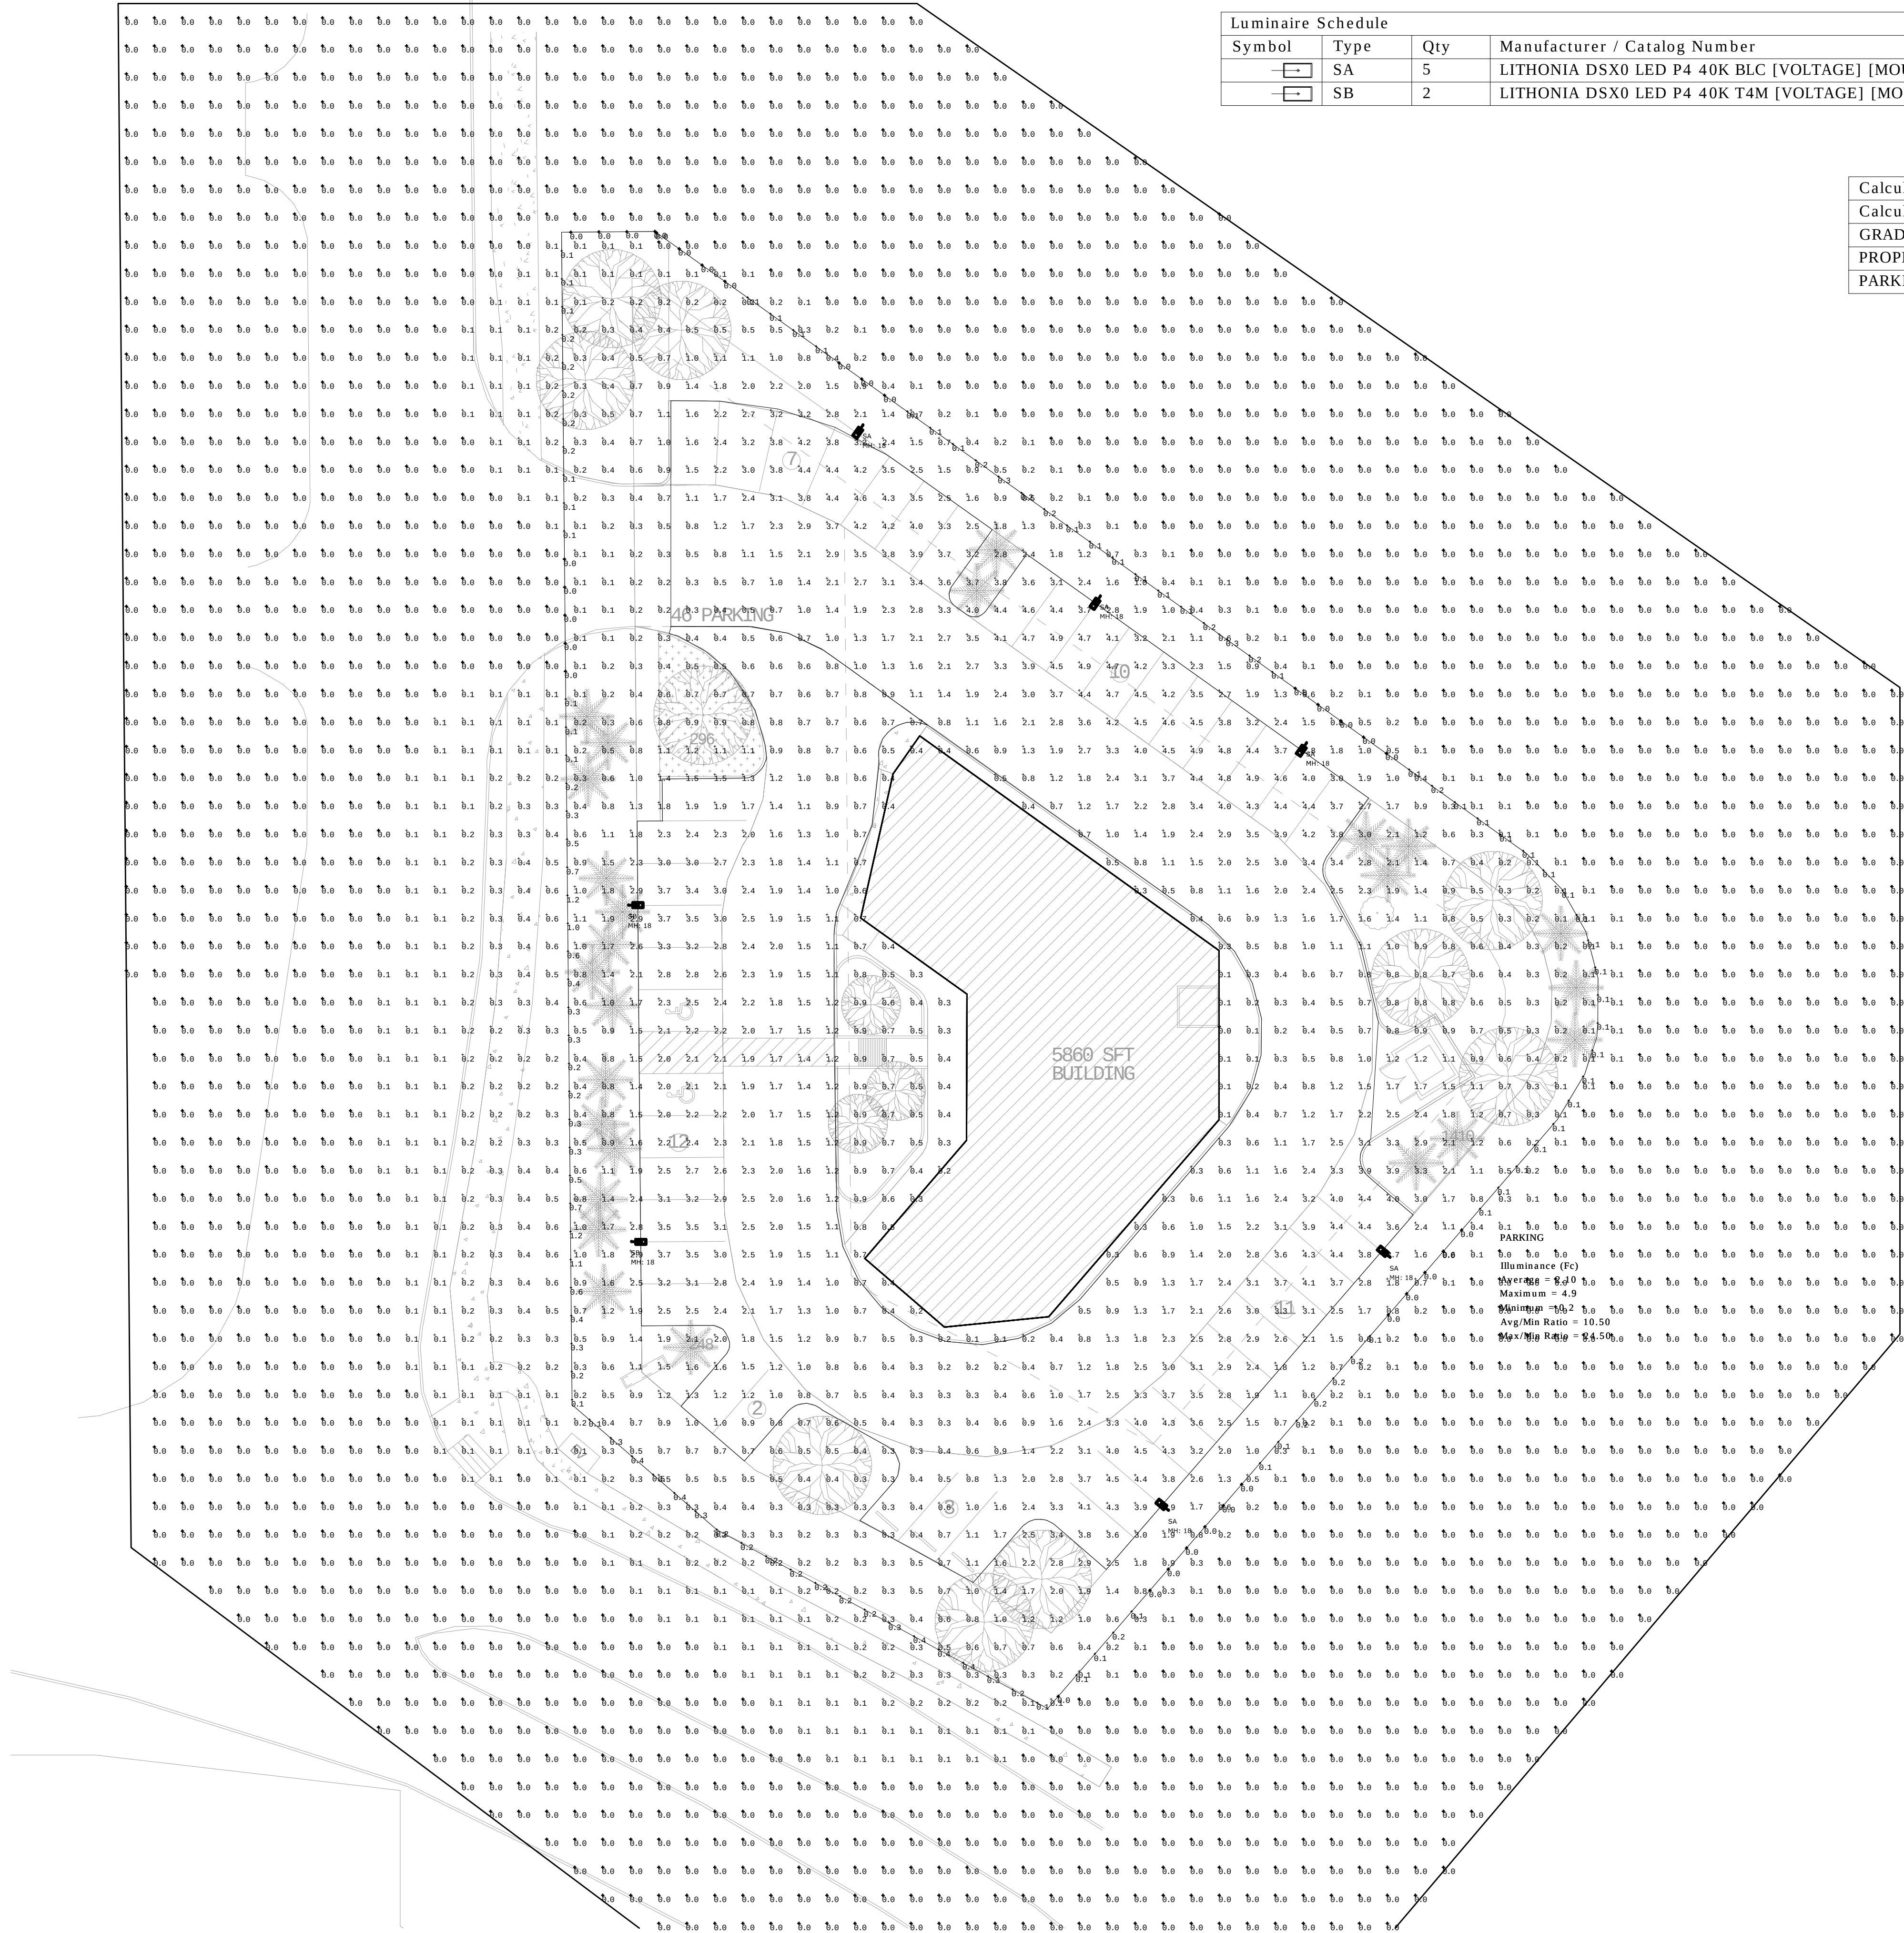


Luminaire Schedule				Total	Total	Ballast	Light	User Defined
Symbol	Type	Qty	Manufacturer / Catalog Number	Lumen Output	Input Watts	Factor	Lost Factor	Factor
	SA	5	LITHONIA DSX0 LED P4 40K BLC [VOLTAGE] [MOUNT] [CONTROLS] [FINISH] DM19AS	8655	92	1.000	1.000	1.000
	SB	2	LITHONIA DSX0 LED P4 40K T4M [VOLTAGE] [MOUNT] [CONTROLS] [FINISH] DM19AS	10334	92	1.000	1.000	1.000

Calculation Summary						
Calculation Grid Location	Calc. Height (Ft.)	Units	Avg	Max	Min	Avg/Min
GRADE_Planar	0	Fc	0.48	4.9	0.0	N.A.
PROPERTY LINE	N.A	Fc	0.18	1.2	0.0	N.A.
PARKING		Fc	2.10	4.9	0.2	10.50

DATE: 01/05/2018
REVISION#: _____

RETAIL CENTER FOR
VILLAGE OF COTTONWOOD CREEK
911 N. COPPELL ROAD, COPPELL, TEXAS

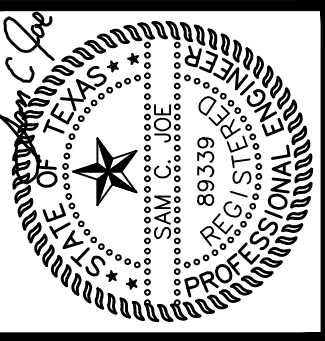

AZEN MECHANICAL CORPORATION
9078 EVER TRAILS BLVD.
FORT WORTH, TEXAS 76118
PH: 817-228-3321
REGISTRATION NUMBER
F-8409

SHEET NO.
MEP1
OF