
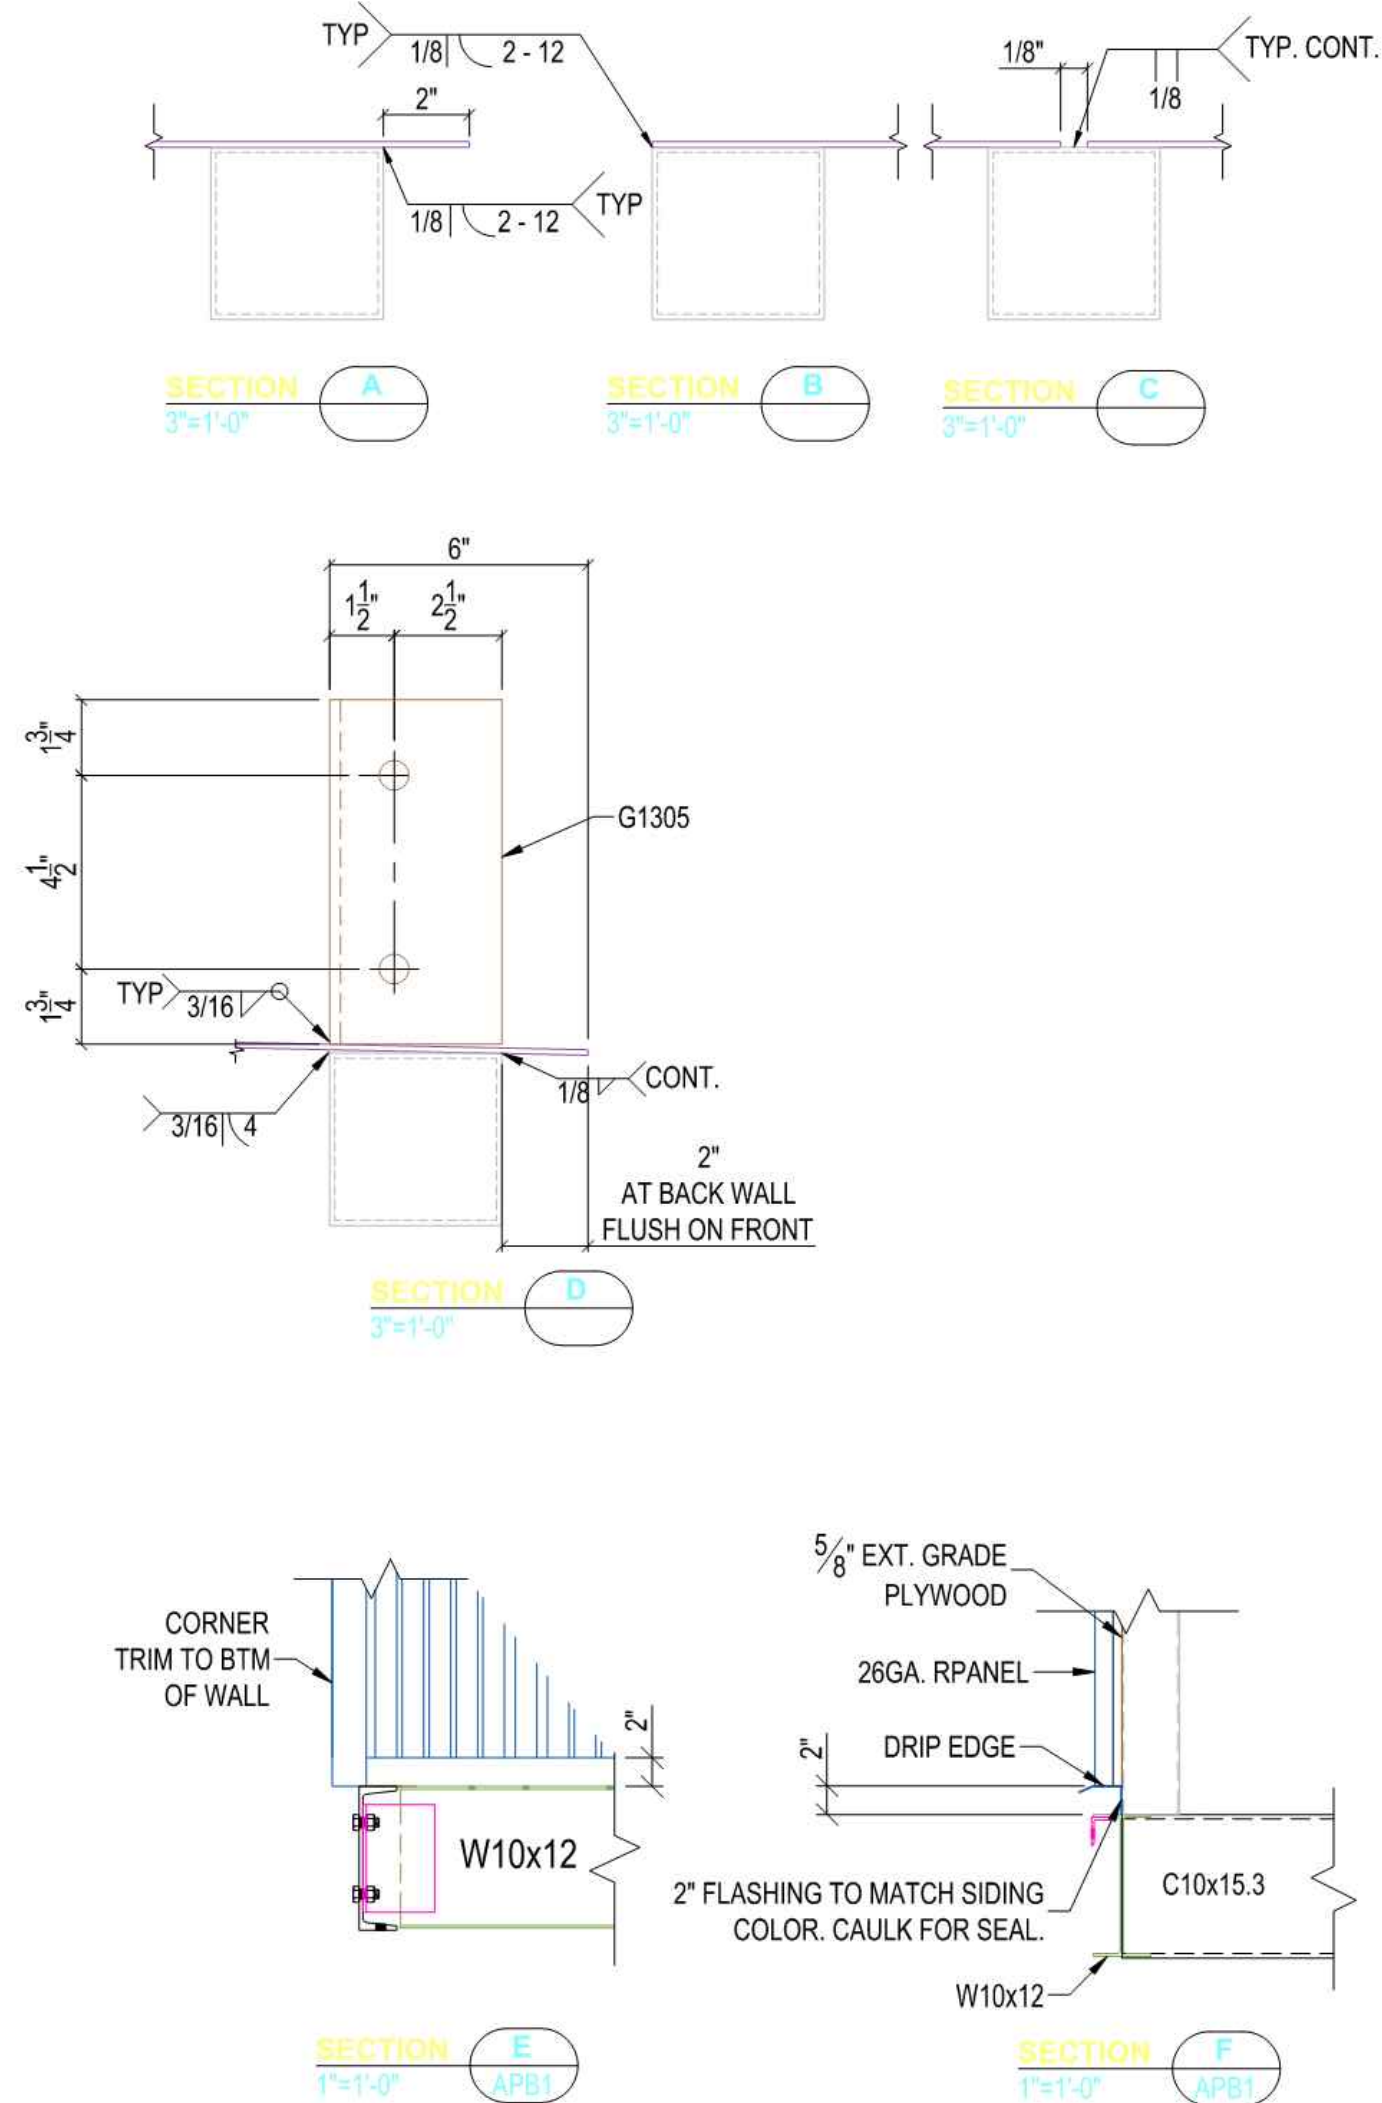


Plotted: Feb 2, 2018, 10:10 AM by user: robert - Saved: 2/2/2018 by user: robert - Section D: Panelboard Project: COPPELL MIDDLE SCHOOL EAST 2017 TRACK AND TURF P&S - ANS 2 COMMENTS 2017 MOCK CITY SITE PLAN REV 2.dwg

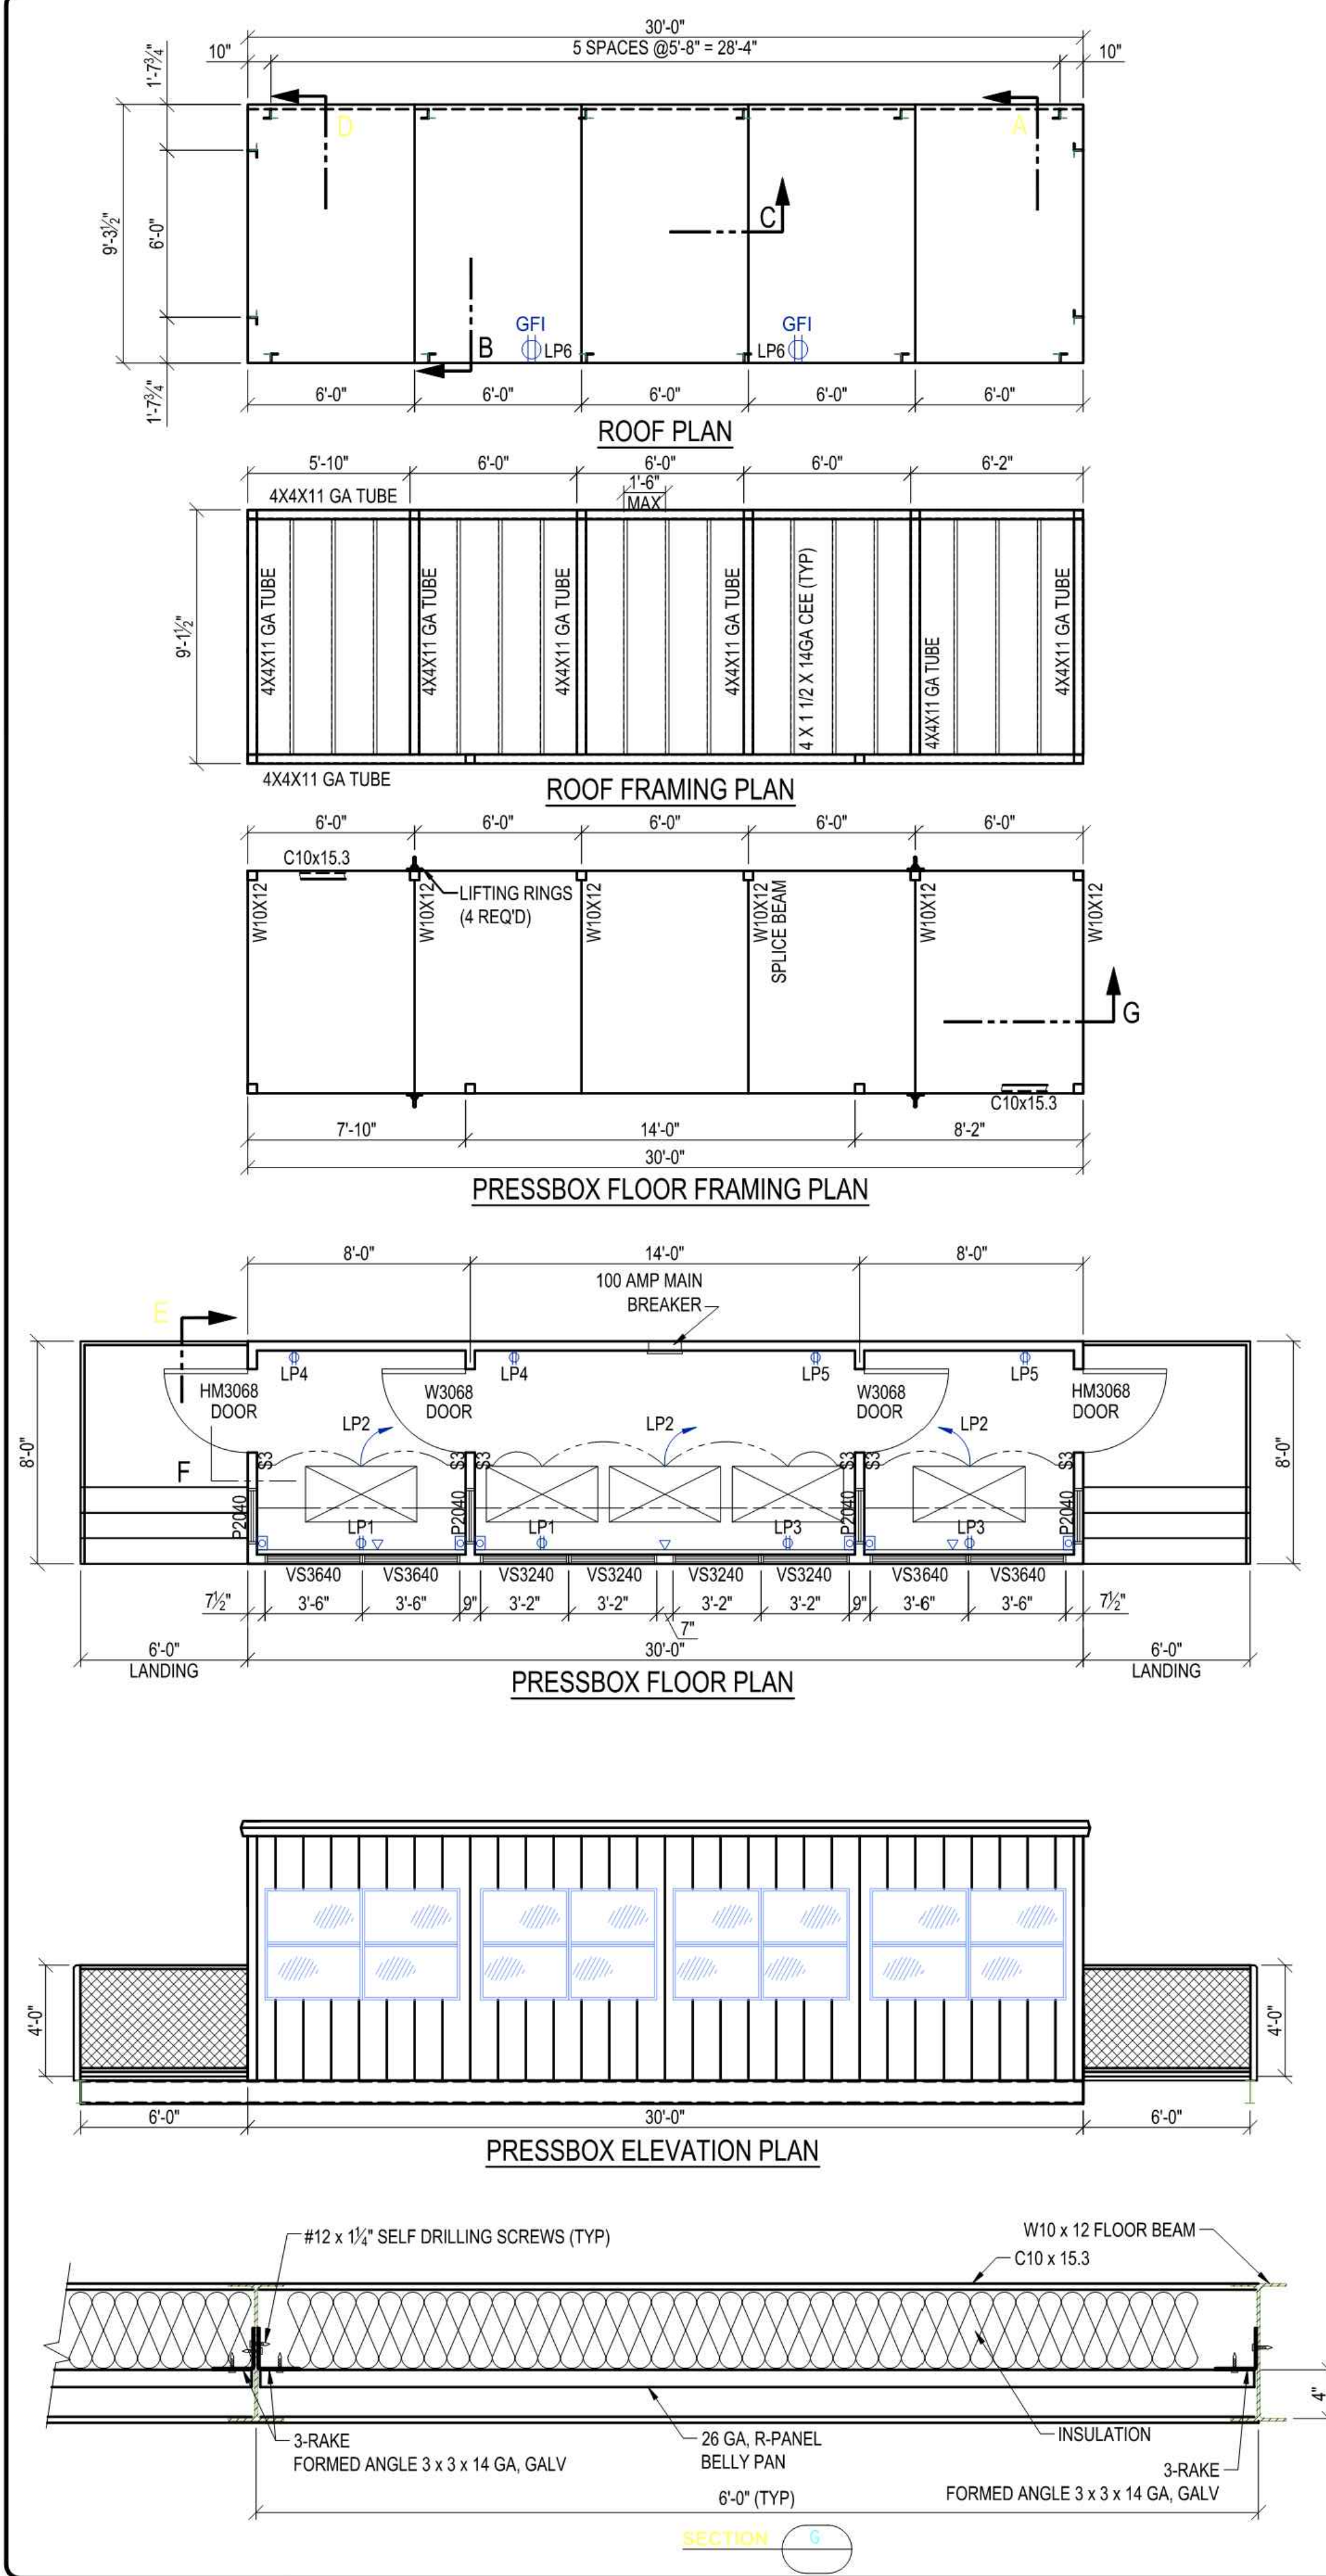



PANELBOARD SCHEDULE			
SQUARE 'D' HOM20M100C			
PANEL LP	100 AMP - 20 CIRCUIT W/ EQUIPMENT GROUND	240/120 VOLTS	1 PH.
MOUNTING: ☒ FLUSH ☐ SURFACE	10,000 SYN. A.I.C. MIN.	100 AMP MAIN BREAKER	
RECEPT. FRONT WALL	20 1 1	2 1 20	2X4 RECESSED LAMPS RECESSED
RECEPT. FRONT WALL	20 1 3	4 1 20	RECEPT. REAR WALL
RECEPT. REAR WALL	20 1 5	6 1 20	GFI RECEPT. FILM DECK
SPARE	20 1 7	8 1 20	SPARE
SPARE	20 1 9	10 1 20	SPARE
SPACE	20 1 11	12 1 20	SPACE

ELECTRICAL NOTES:

- ALL WORK SHALL MEET NATIONAL ELECTRICAL CODE AND ALL COMPONENTS TO BE UL LISTED.
- 240V/120V, 1PH 100A MAIN BREAKER W/ A MIN OF 12 SPACES, SQUARE D HOMELINE OR EQUAL, FLUSH MOUNTED INSIDE BUILDING W/ 1 1/2" CONDUIT STUBBED OUT THROUGH PBOX FLOOR FOR SERVICE LINE TO BE CONNECTED BY OTHERS.
- WIRING THROUGHOUT TO BE PRE-WIRED USING TYPE MC CABLE.
- 110V DUPLEX OUTLET @ 18" A.F.F., ONE EVERY 8'-0" UNO.
- GFI 20A GROUND FAULT INTERRUPTER OUTLET IN WATERPROOF ALUMINUM BOX.
- 2-BULB, 40W, 4'-0" FLOURESCENT LIGHT FIXTURE, ONE EVERY 8'-0", SURFACE MOUNTED UNO.
- S STANDARD WALL SWITCH, 42" A.F.F.
- 4"x4"x2" GANG BOX W/ 3/4" CONDUIT STUBBED THROUGH PBOX FLOOR FOR OWNER'S USE.
- PHONE JACK SINGLE BOX W/ 3/4" CONDUIT STUBBED THROUGH PBOX FLOOR FOR CONNECTION BY OTHERS.

ARCHITECTURAL NOTES:

- WB = 20" WIDE PRE-FORMED PLASTIC LAMINATE WORK BENCH CONSTRUCTED OF DOUBLE 3/4" AC GRADE PLYWOOD, COUNTER TOP 32" A.F.F., SUPPORTED W/ 2"x2"x1/8" ANGLE BRACKETS @ 32" OC. COLOR: NATURAL ALMOND
- HM3068 = 3'-0"x6'-8" INSULATED EXTERIOR HOLLOW METAL DOOR AND FRAME W/ ALUMINUM THRESHOLD AND WEATHERSTRIPPING. HARDWARE EQUAL TO PDQ, DULL CHROMIUM PLATED US 26D, LEVER HANDLE, KEYS ALIKE.
- VS3240 = 3'-2"x4'-0" SINGLE HUNG ALUMINUM WINDOW, DOUBLE GLAZED, WITH TEMPERED GLASS, VERTICAL SLIDING TYPE.
- VS3640 = 3'-6"x4'-0" SINGLE HUNG ALUMINUM WINDOW, DOUBLE GLAZED, WITH TEMPERED GLASS, VERTICAL SLIDING TYPE.
- P2040 = 3'-0"x4'-0" PICTURE WINDOW, DOUBLE GLAZED, WITH TEMPERED GLASS.

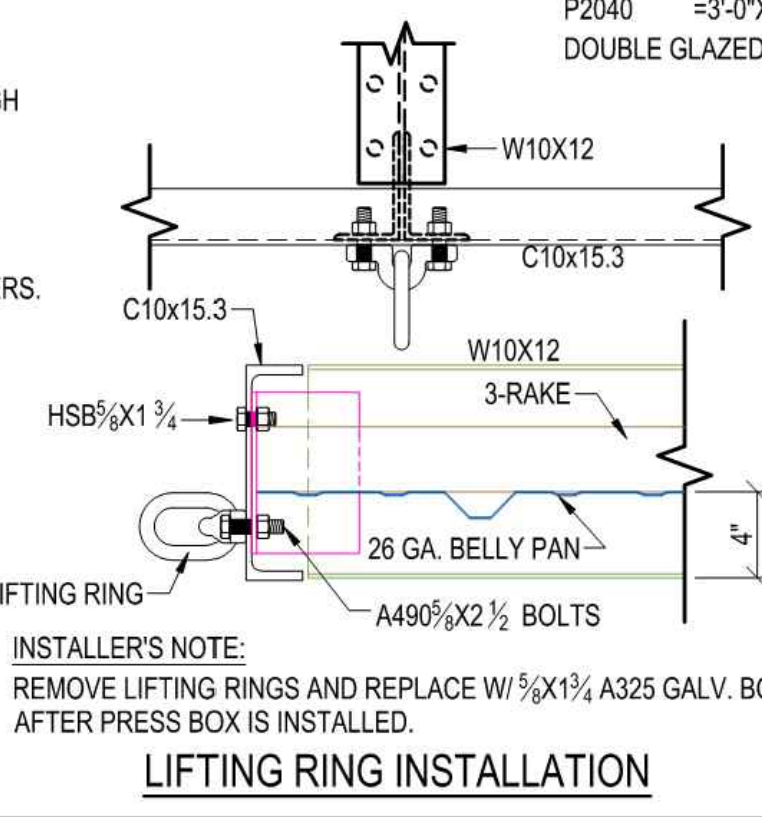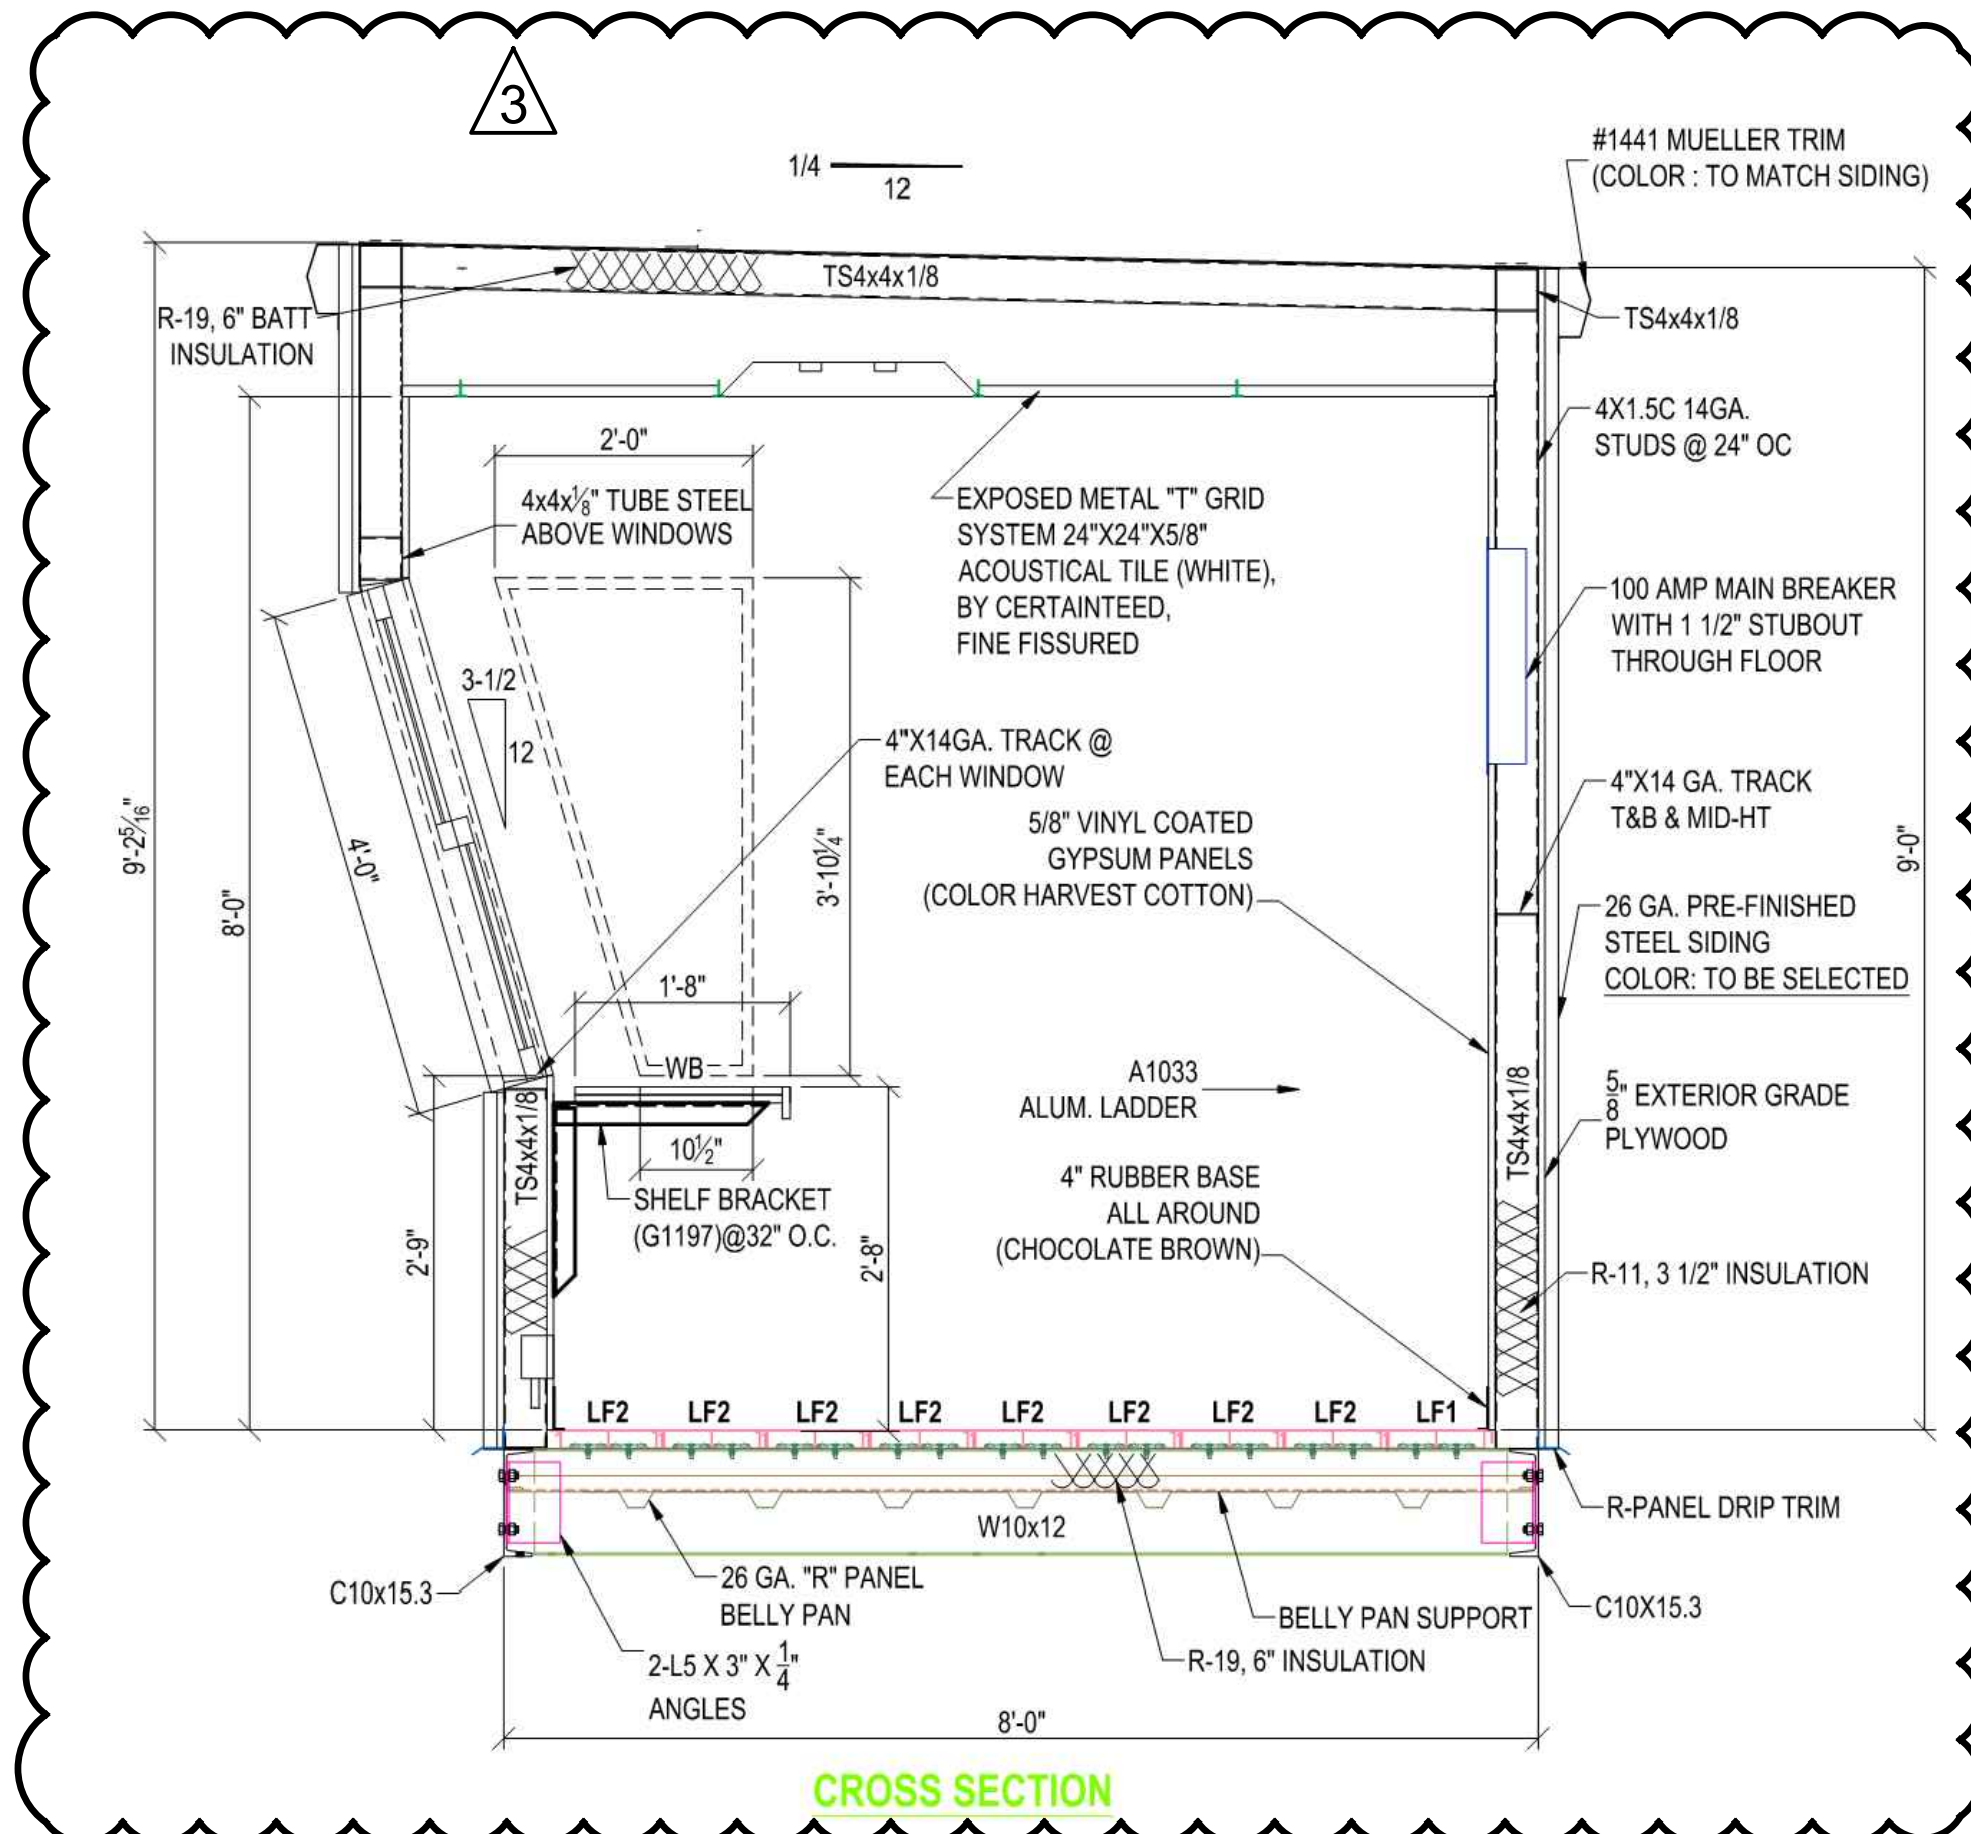

REVISIONS			
NO.	DATE	DESCRIPTION	BY
1	10/11/13	SALES DRAWING	JR
2	12/11/17	ADDENDUM #1	City Comments
3	01/30/18	P and Z Comments	
4			
5			
6			
100			

GLENN ENGINEERING
TEXAS REGISTRATION NUMBER: F-303
PHONE 972-77-3551
105 DECKER COURT, SUITE 910
IRVING, TEXAS 75062

ISSUED FOR
COPPELL MIDDLE SCHOOL EAST -
TRACK SURFACE AND FIELD TURF
REPLACEMENT - BB #47615
COPELL, TEXAS

ISD
COPPELL ISD - BUSINESS OFFICE
31303 WRANGLER CIRCLE
COPELL, TEXAS 75019
ATTN: SID GRANT

PROJECT ADDRESS:
COPPELL MIDDLE SCHOOL EAST
400 MOCKINGBIRD LANE
COPELL, TEXAS 75019

Revisions:

NO.	DATE	DESCRIPTION
1	03/18/17	ADDENDUM #1
2	12/11/17	City Comments
3	01/30/18	P and Z Comments
4		
5		
6		
100		

Issue Dates:
Review: 03-06-2017
Permit:
Construction:
Scale: AS SHOWN
Drawn By: RAH
Checked By: CMC
Project No: Buy Board#47615

Job Number:
XXX-XXXX
Sheet Number:
APBI

Sheet
C5

THIS SHEET IS FOR REFERENCE ONLY